


ELECTRICAL SCHEDULE	
SYMBOL	DESCRIPTION
	Ceiling light
	Wall Light
	Recessed Downlight
	Bunker Light
	Round Fluorescent Light
	Fluorescent Bar Light
	Hollywood Lights
	Spotlight
	Smoke Alarm
	Exhaust Fan
	Telephone Point
	T.V. Aerial Point
	Double Power Point
	Single Power Point
	Double Waterproof Power Point
	Under Bench Oven (Permanently Wired)
	Hotplate (Permanently Wired)
	Rangehood (Single Power Point)
	Dishwasher Space (Double Power Point)
	Hotwater System (Gas Supply)
	Ceiling Fan with Light
	Ceiling Fan

QLD SUSTAINABLE HOUSE CODE
ENERGY EFFICIENT LIGHTING
 FLOURESCENT LIGHTS OR COMPACT FLOURESCENT LIGHTS (CFLs) ARE TO BE USED IN 80% OF THE TOATL AREA OF ALL ROOMS. AREA MEASURED TO INCLUDE GARAGE.

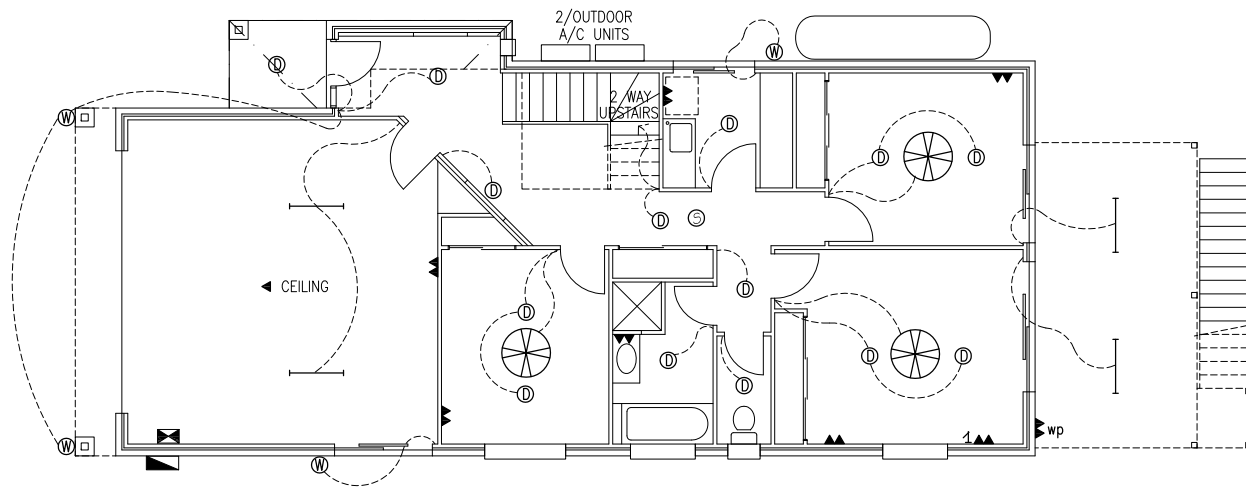

VER	DATE	DESCRIPTION



ALAN BRIND
 DESIGN & CAD DRAFTING PTY LTD
 8 Kaoyong Crt, FERNY GROVE, Q, 4055. Fax 3851 3796. Ph 3851 3166

BSA LIC. 75230 ACN 072 663 364

PROJECT: _____
 AT: _____

SCALE: 1:100 at A3
 DRAWN: A. Brind
 FOR: _____

DRAWING TITLE: **LOWER LEVEL ELECTRICAL PLAN**

JOB I.D.: _____
 DWS No: **W12**
 VER: **A**